


W.R. & A. B.M. "B-2" Elev. - 449.92
 R.R. spike in base of Power Pole #325769
 on S.W. side of Brittany Drive, 150' ± S.E.
 of Roberts Road.

PLAN
 Scale: 1"=50'

GENERAL NOTES

1. Approximate location of existing mains are shown. The Contractor shall take all necessary precautions to protect existing mains and services and maintain uninterrupted supply.
2. All pipe elevations shown are invert elevations.
3. The Contractor shall locate existing utilities a minimum of two weeks in advance of construction operations in vicinity of utilities.
4. For all standard details see Standards bound in Specifications.
5. All water mains to be C.I.P. Class 22 and have a minimum of 3 1/2' cover.
6. Block all fittings with concrete, see standard details bound in specifications.
7. Bury line elevation on fire hydrant shall be set the same as edge of paving or as directed by the Engineer in the field.
8. Buttress fire hydrants with concrete; provide copper pipe for weep holes as required for positive drainage. For Buttress dimensions see standard detail W-8 Buttress for Caps.

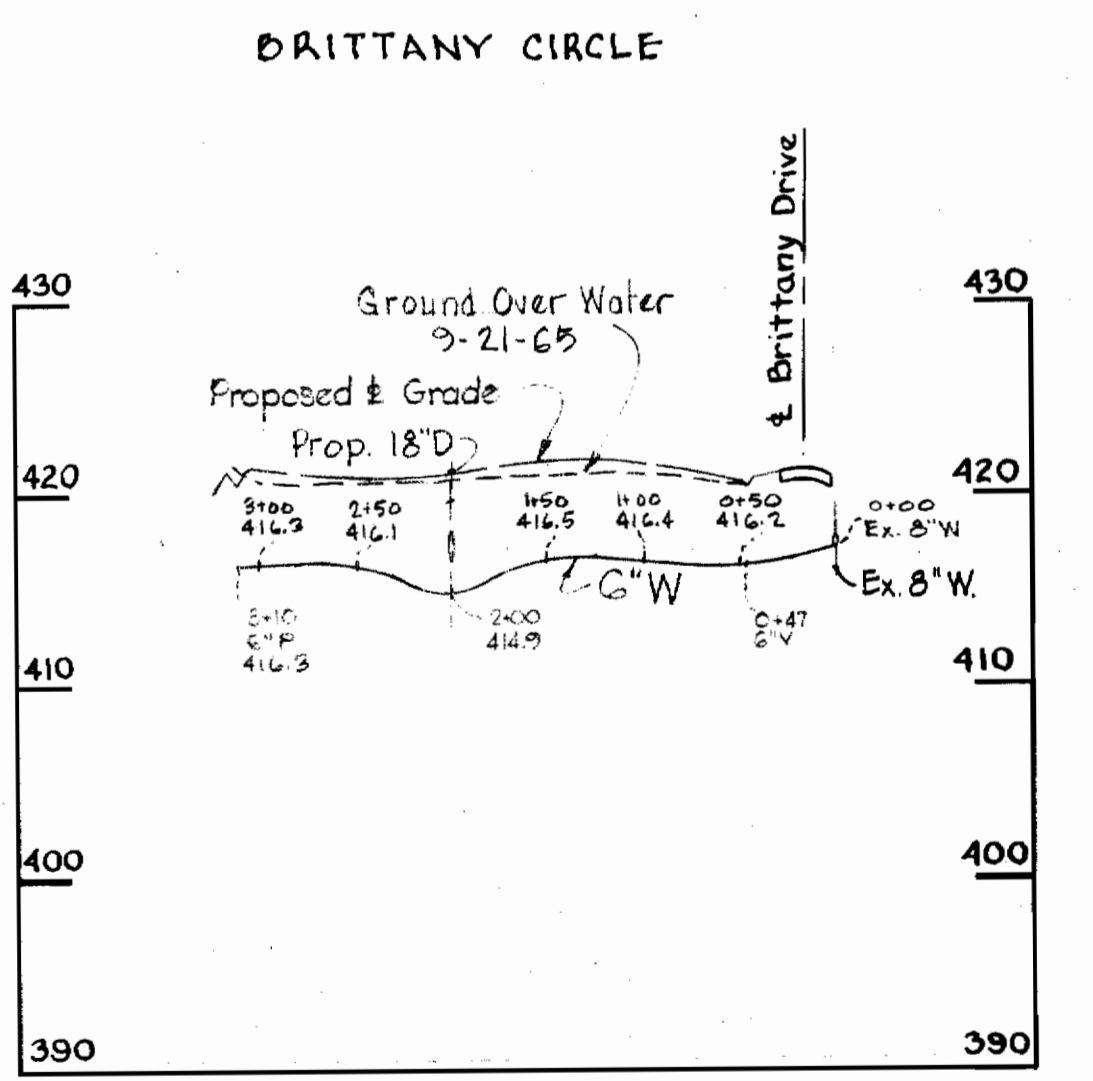

PROFILE
 Scale: Hor. 1"=100'
 Vert. 1"=10'

Contract No. 103-W

WHITMAN, REQUARDT & ASSOCIATES ENGINEERS 1304 ST. PAUL ST. BALTIMORE, MARYLAND	HOWARD COUNTY METROPOLITAN COMMISSION 9-21-65 <i>W. O. Salter</i> <small>DATE</small> <small>CHIEF ENGINEER</small>	CONTRACT NO. 103-W	PLAN AND PROFILE OF WATER MAINS	ELLICOTT CITY SUB-DISTRICT	<table border="1"> <tr> <td>DRAWING NO. 1</td> <td>SCALE AS SHOWN</td> </tr> <tr> <td>OF 1</td> <td>17 5W 37</td> </tr> </table>	DRAWING NO. 1	SCALE AS SHOWN	OF 1	17 5W 37
DRAWING NO. 1	SCALE AS SHOWN								
OF 1	17 5W 37								

W. O. 5129-2

AS BUILT 20 NOV. 65

WS 103W/1