


PLAN
Scale 1"=50'

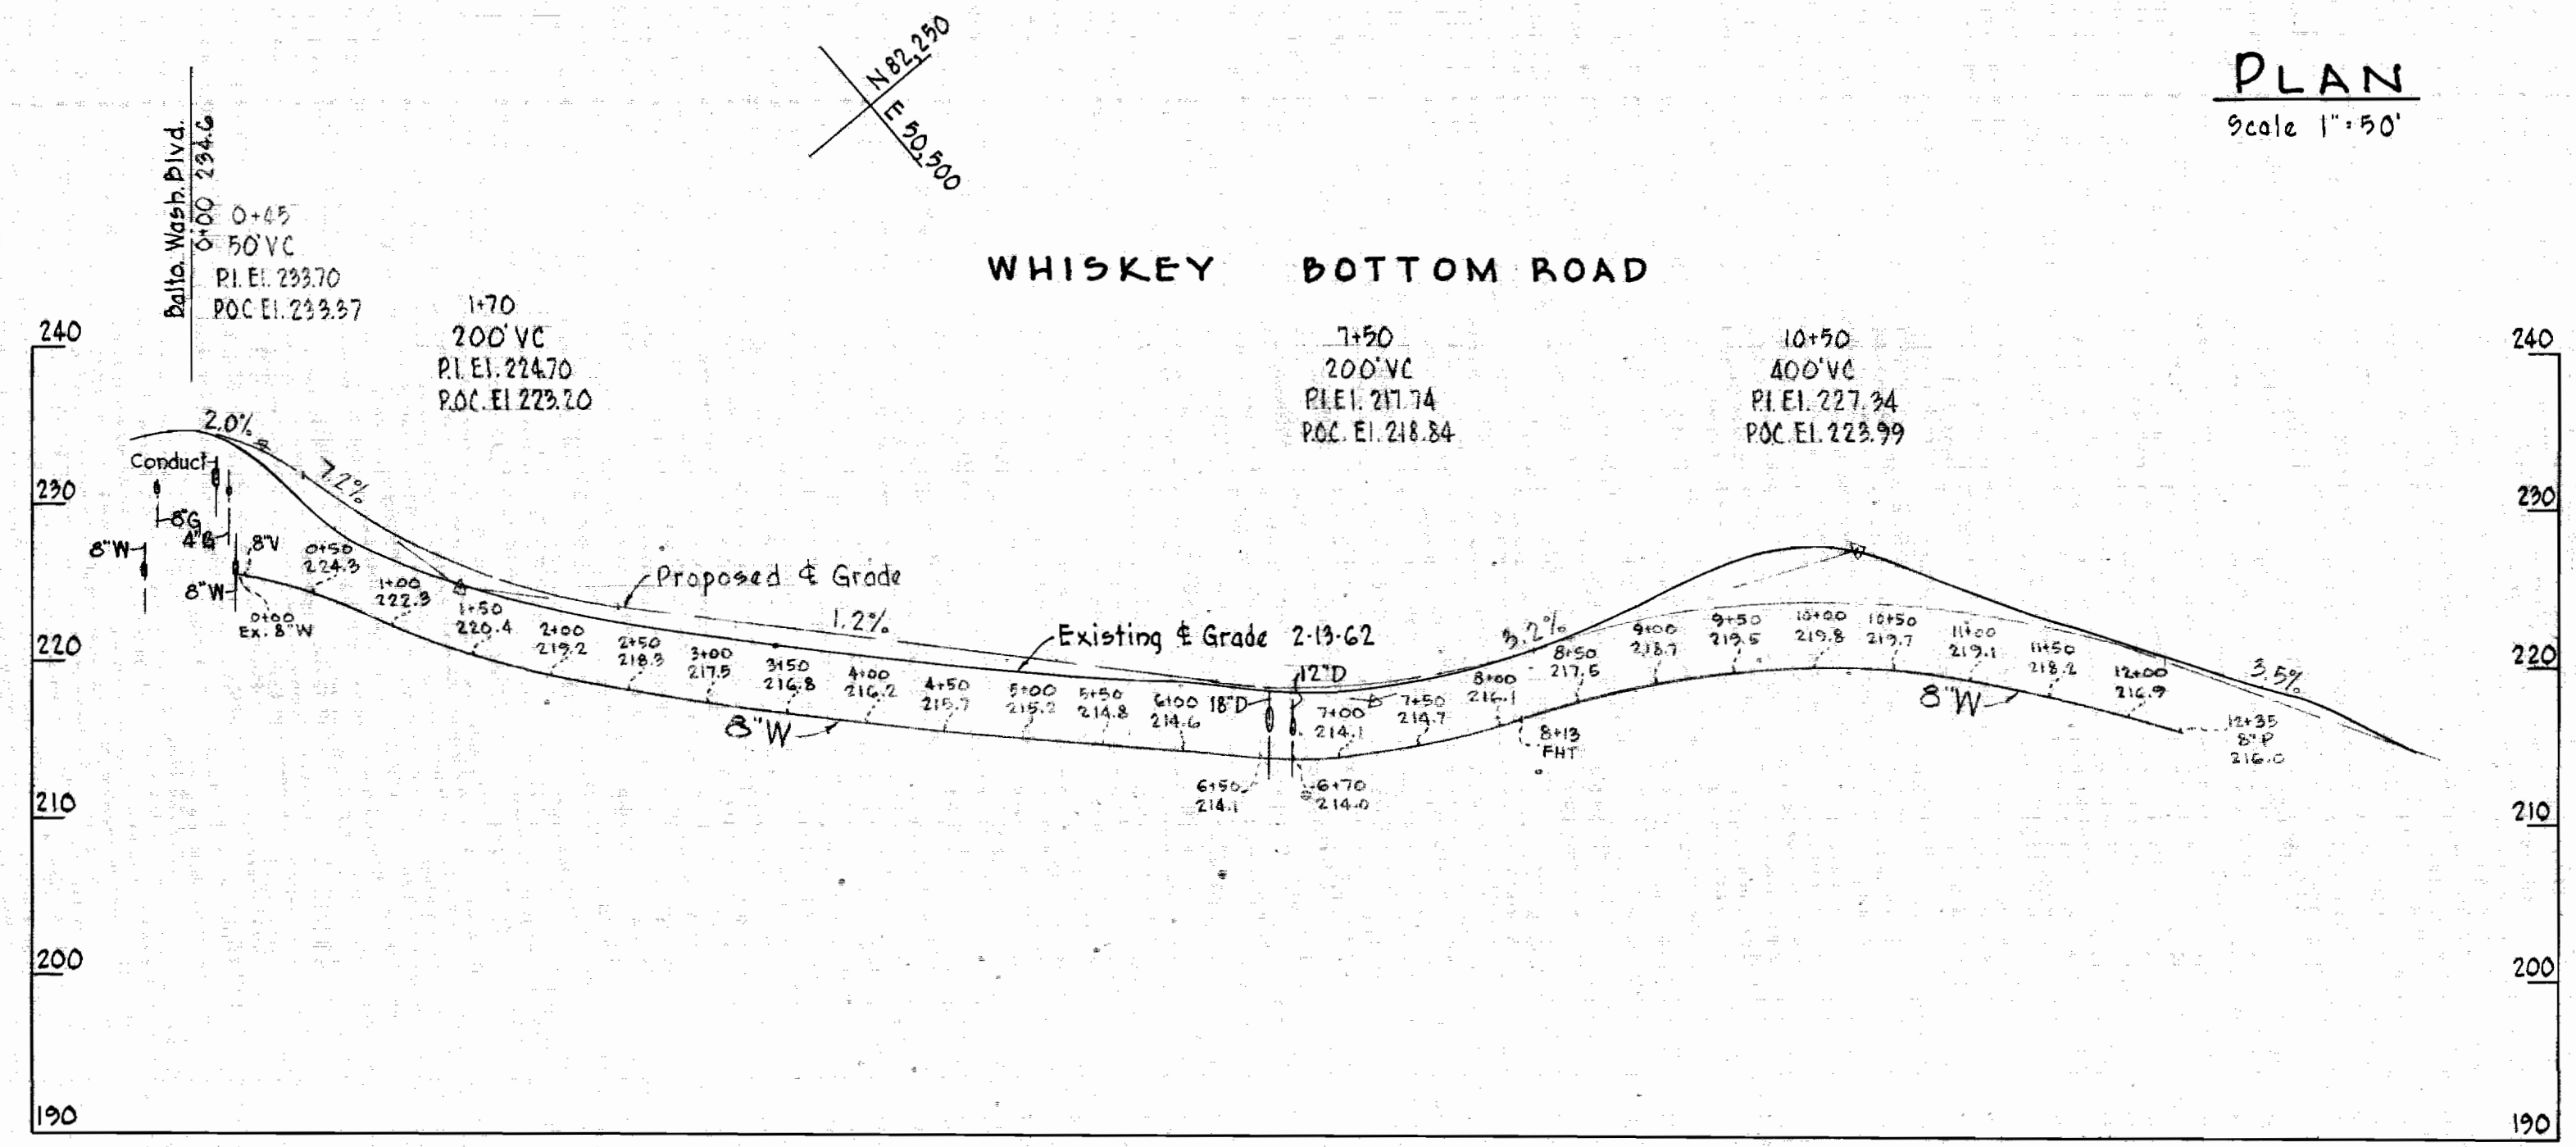

PROFILE
Scale Vert. 1"=10'
Horz. 1"=100'

W.R.&A B.M.#1 Elev. 219.08
R.R. spike in base of G&E Pole #123610
on West side of road opposite ice
cream plant.

- Note:
1. All water pipe to be cast iron Class 22
 2. Use concrete to block all fittings, see standard details.
 3. Bury line elevation on fire hydrant shall be set the same as edge of paving or as directed by the Engineer in the field.

AS BUILT

WASHINGTON SUBURBAN SANITARY COMMISSION APPROVED FOR WATER ONLY	
<i>Charles A. ...</i> CHIEF ENGINEER	2-26-62 DATE
DRAWING NO. 1 OF 1	SCALE AS SHOWN
62024	

WHITMAN, REQUARDT & ASSOCIATES
ENGINEERS
1304 ST. PAUL ST.
BALTIMORE, MARYLAND

HOWARD COUNTY METROPOLITAN COMMISSION
DATE Feb. 13, 1962
Carl W. Meyer
CHIEF ENGINEER

CONTRACT NO. 41-W

PLAN AND PROFILE OF
WATER MAIN

PATUXENT SUB-DISTRICT

W. O. 5129-2

JUNE 13, 1962

WS 41W/1