


VICINITY MAP
Scale: 1/2" = 1 Mile

GENERAL NOTES

1. Approximate location of existing mains are shown. The Contractor shall take all necessary precautions to protect existing mains and services and maintain uninterrupted supply. Any damage incurred shall be repaired immediately.
2. All pipe elevations shown are invert elevations.
3. The Contractor shall locate existing utilities a minimum of two weeks in advance of construction operations in vicinity of utilities.
4. For all standard details see standards bound in Specifications.
5. Clear all utilities by a minimum of 6'; clear all poles by 2'-0" minimum or tunnel as required.
6. All water mains to have a minimum of 3 1/2' cover unless otherwise noted.
7. Block all fittings with concrete, see standards bound in Specifications.
8. All fire hydrants shall be strapped to the tee and shall be buttressed with concrete in accordance with standard Details.
9. All horizontal and vertical controls are based on Maryland State Datum.
10. All lots require pressure reducing valves to avoid excessive pressures (not included in this contract).

AS BUILT
STAKEOUT AND DIARY IN FB # 5286
F.H. - M.H.
3/4" COPPER USED FOR M.H.C.'s

QUANTITIES	
ITEM	QUANTITY
8" Water	2,687 L.F.
Fire Hydrants	4

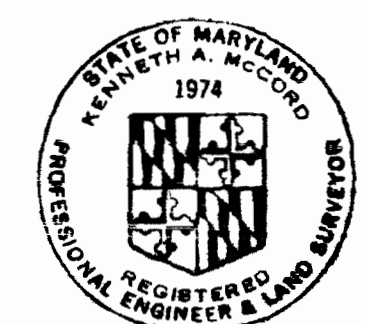


Kenneth A. McCord

Ducketts Lane
Project No. WR 80-40
Contract No. 510-W


PLAN
Scale: 1" = 50'

WHITMAN, REQUARDT & ASSOCIATES ENGINEERS 1304 ST. PAUL ST. BALTIMORE, MARYLAND	DEPARTMENT OF PUBLIC WORKS HOWARD COUNTY, MARYLAND DATE: 2-1-73 W. O. Falbert CHIEF - BUREAU OF WATER AND SEWER	CONTRACT NO. 510-W	PLAN OF WATER MAINS	ELECTION DISTRICT ELKRIDGE NO. 1	DRAWING NO. 1 OF 2 SCALE AS SHOWN
--	--	---------------------------	----------------------------	---	--

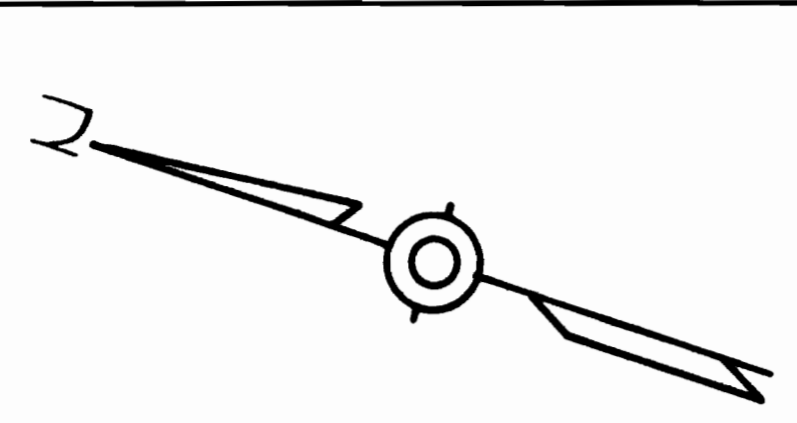

499.500U
871.500E
F.F. 2007.3


FF=194.17

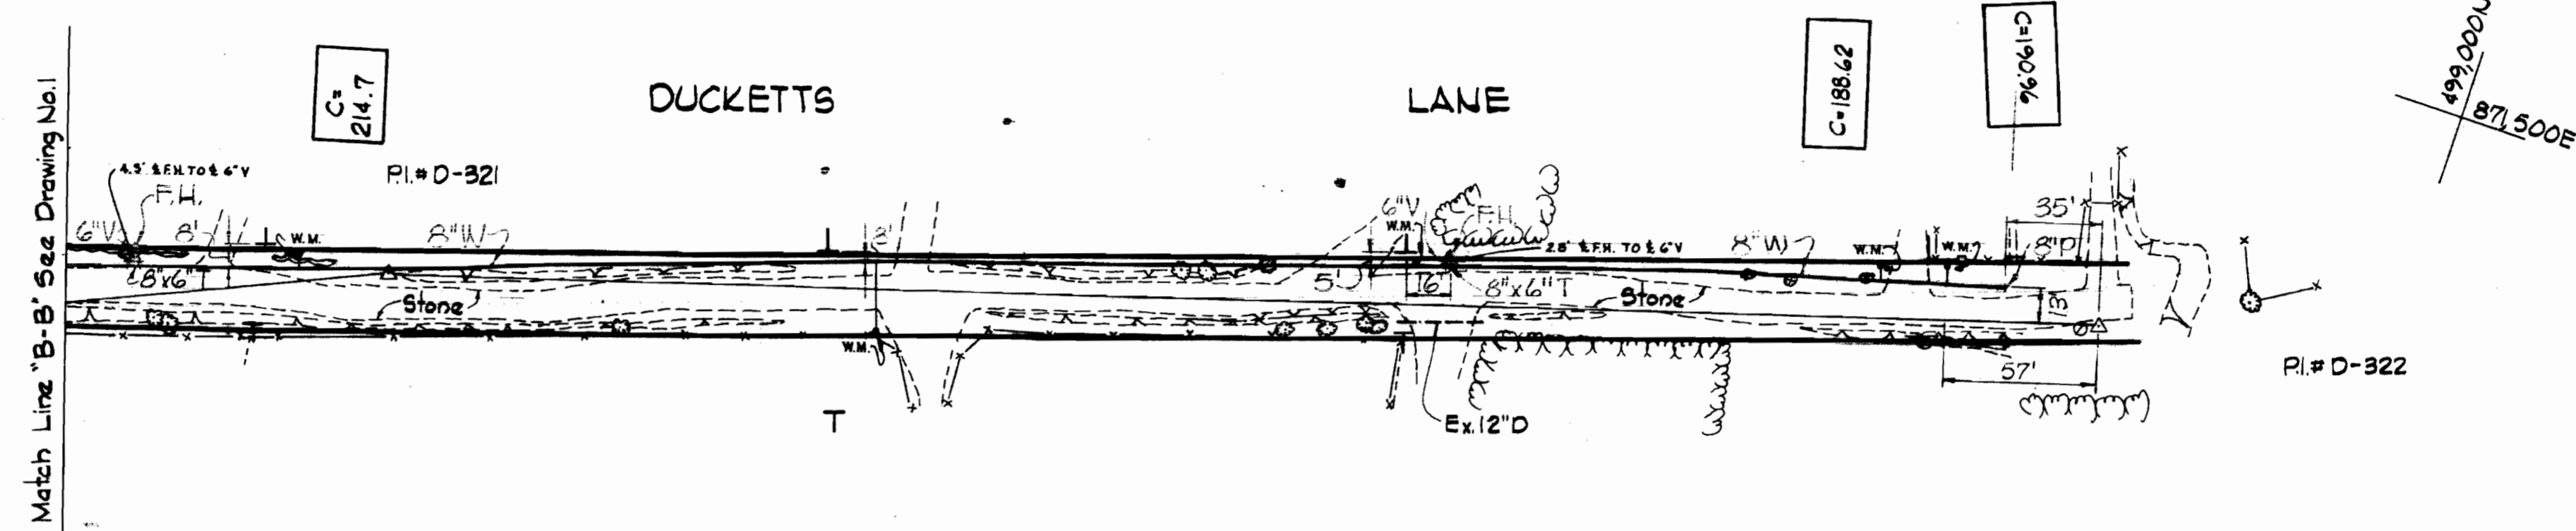

PLAN
Scale: 1"=50'

499.750U
871.000E

44.331
Hart Club Road

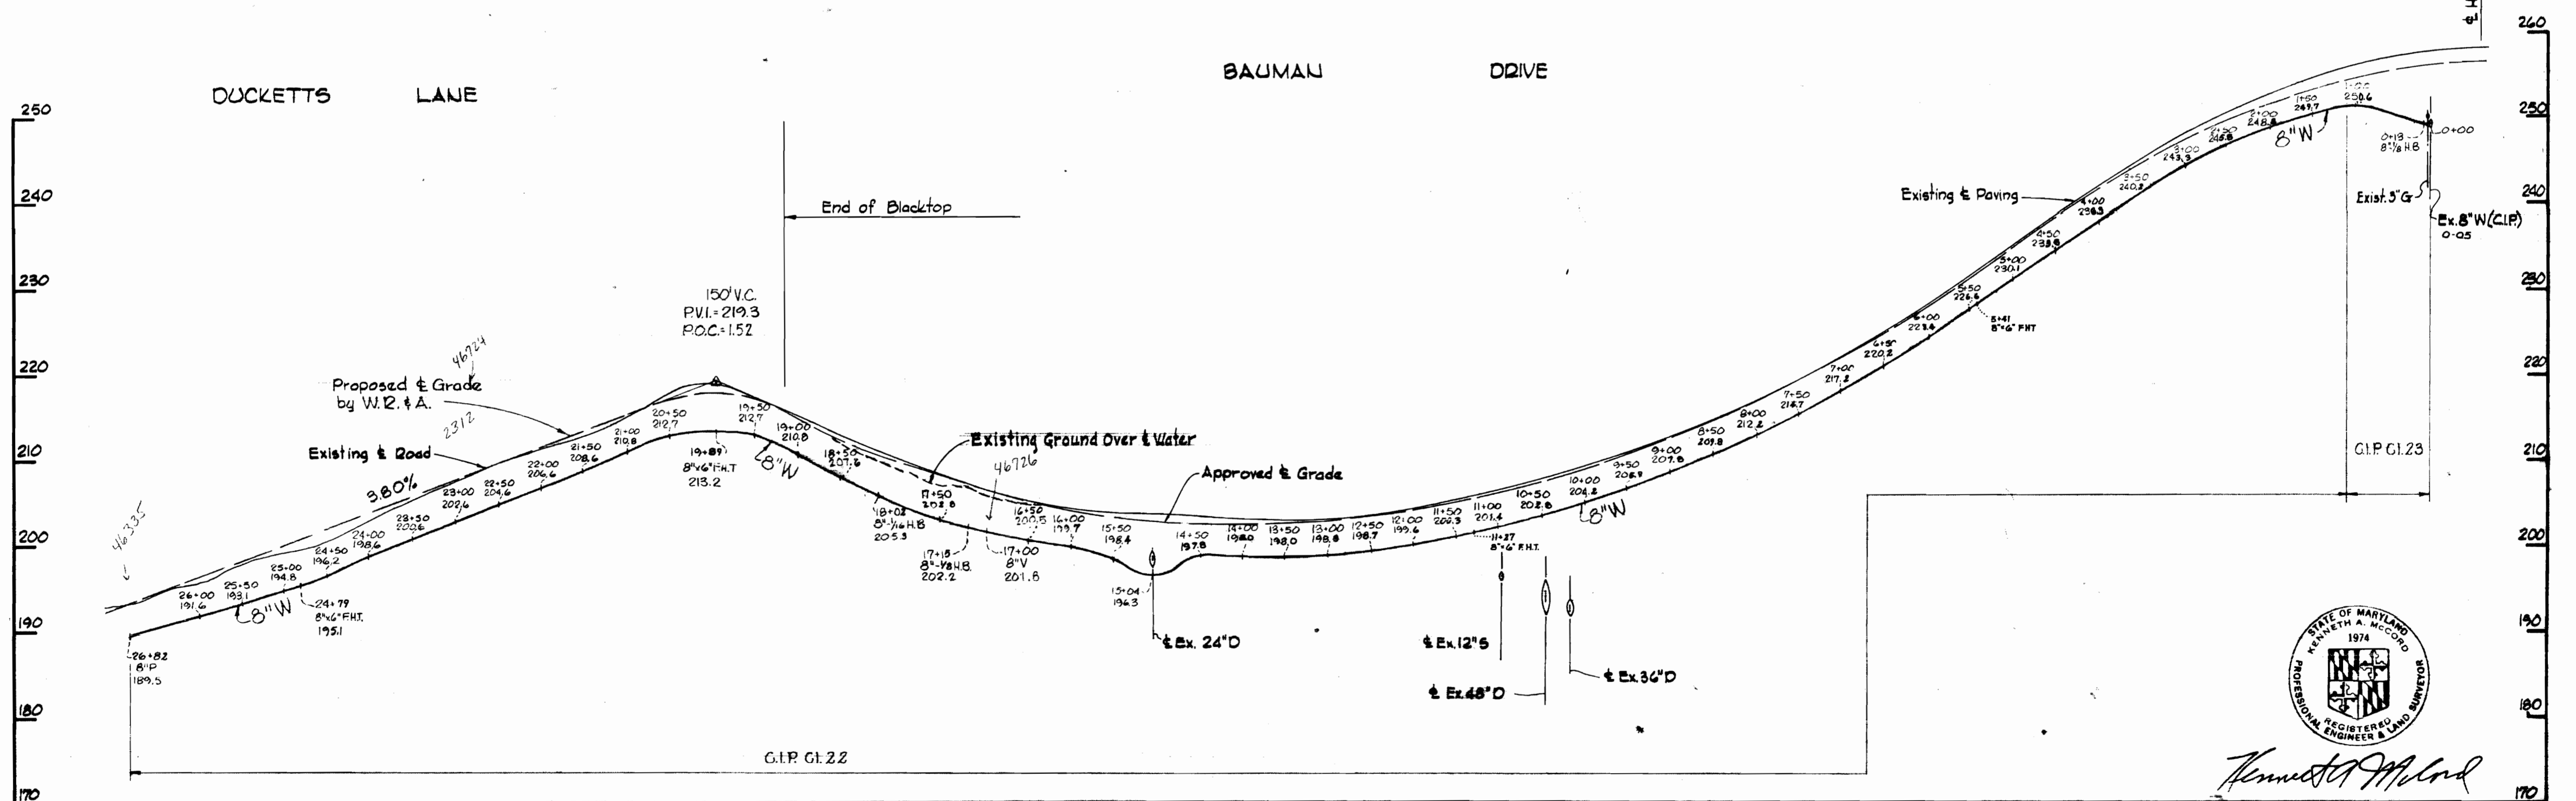

PROFILE
Scale: Horiz. 1"=100'
Vert. 1"=10'



Kenneth A. McCord

Ducketts Lane
Project No. W.P. 8040
Contract No. 510-W

WHITMAN, REQUARDT & ASSOCIATES ENGINEERS 1304 ST. PAUL ST. BALTIMORE, MARYLAND	DEPARTMENT OF PUBLIC WORKS HOWARD COUNTY, MARYLAND DATE 2-1-73 <i>W. O. Fullmer</i> CHIEF - BUREAU OF WATER AND SEWER	CONTRACT NO. 510-W	PLAN AND PROFILE OF WATER MAINS	ELECTION DISTRICT ELKRIDGE NO. 1	DRAWING NO. 2 OF 2 SCALE AS SHOWN
--	---	---------------------------	--	---	--

W. O. 6601-2

AS BUILT JULY 2, 1973 FB: 5281

WS 510-W/2

BRUNING 44-510 14778